

SINGLE LINE DIAGRAM FOR THE POWER EVACUATION FROM THE NEW PV POWER PLANT

NOTES			

REVISIONS, ADDITIONS & ALTERATIONS			
NO	DATE	DESCRIPTION	BY

--

CONSULTANTS


CLIENT	BEC

PROJECT
PROPOSED BEC HYBRID SOLAR PV POWER PLANT WITH BESS

DRAWING NAME

DRAWING NAME

PROJECT NO	A202		
	A201/BFL/1/24	DATE	
		DATE	
REVISION NO	0	SCALE 1:100@A1	

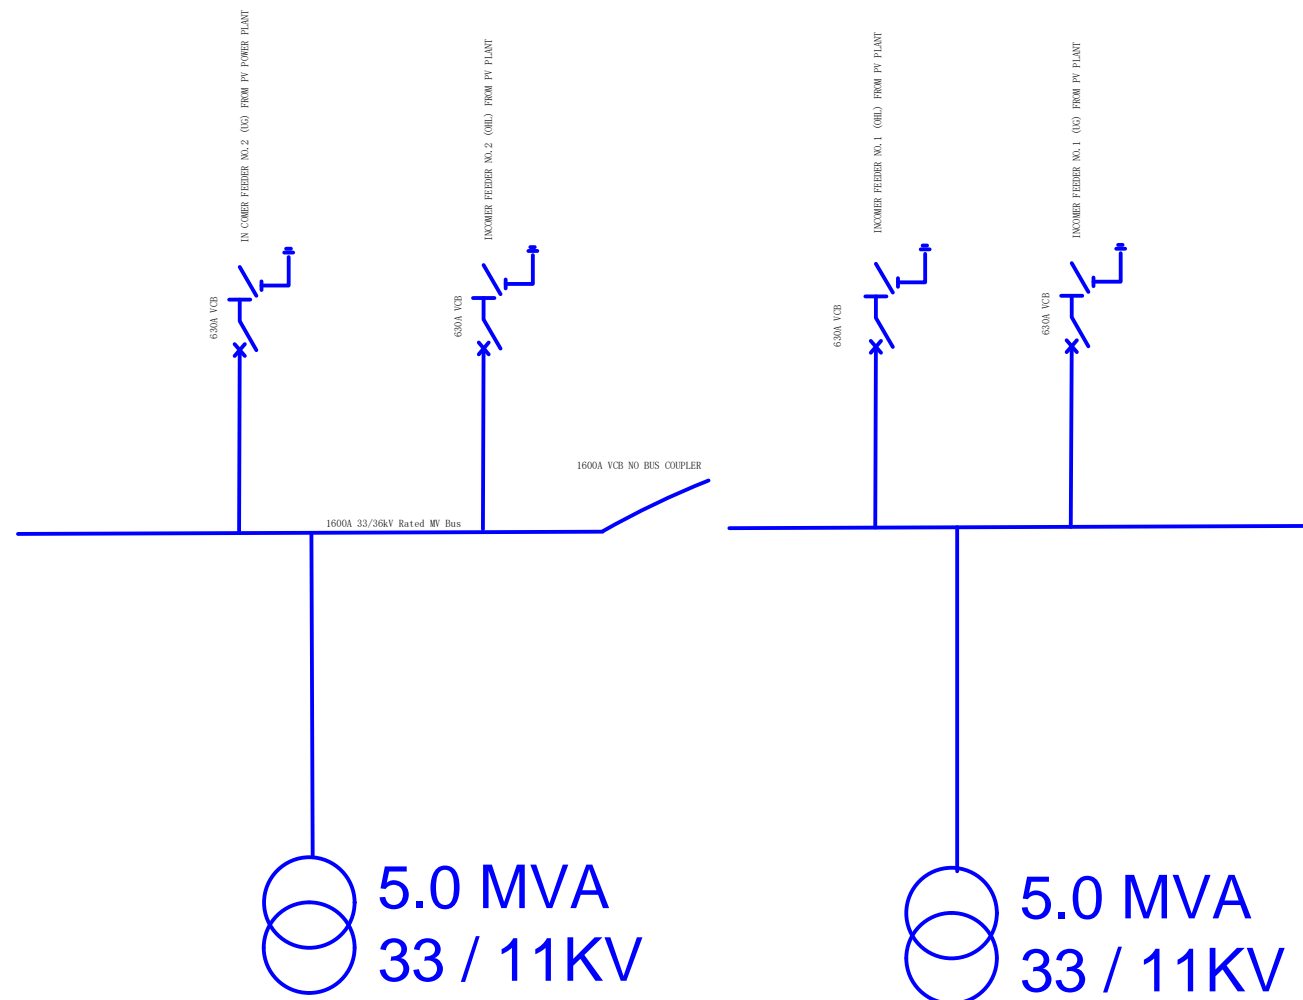

SINGLE LINE DIAGRAM FOR DISTRIBUTION SUBSTATION LOCATED 13.5KM FROM PV POWER PLANT

NOTES	

REVISIONS, ADDITIONS & ALTERATIONS		
NO	DATE	DESCRIPTION

--

CONSULTANTS

CLIENT

PROJECT
PROPOSED BEC DISTRIBUTION SUBSTATION

DRAWING NAME
DRAWING NAME

PROJECT NO	A202		
	A201/BF/L1/24		DATE
			DATE
REVISION NO	0	SCALE	1:100 @A1